



LEVEL 2

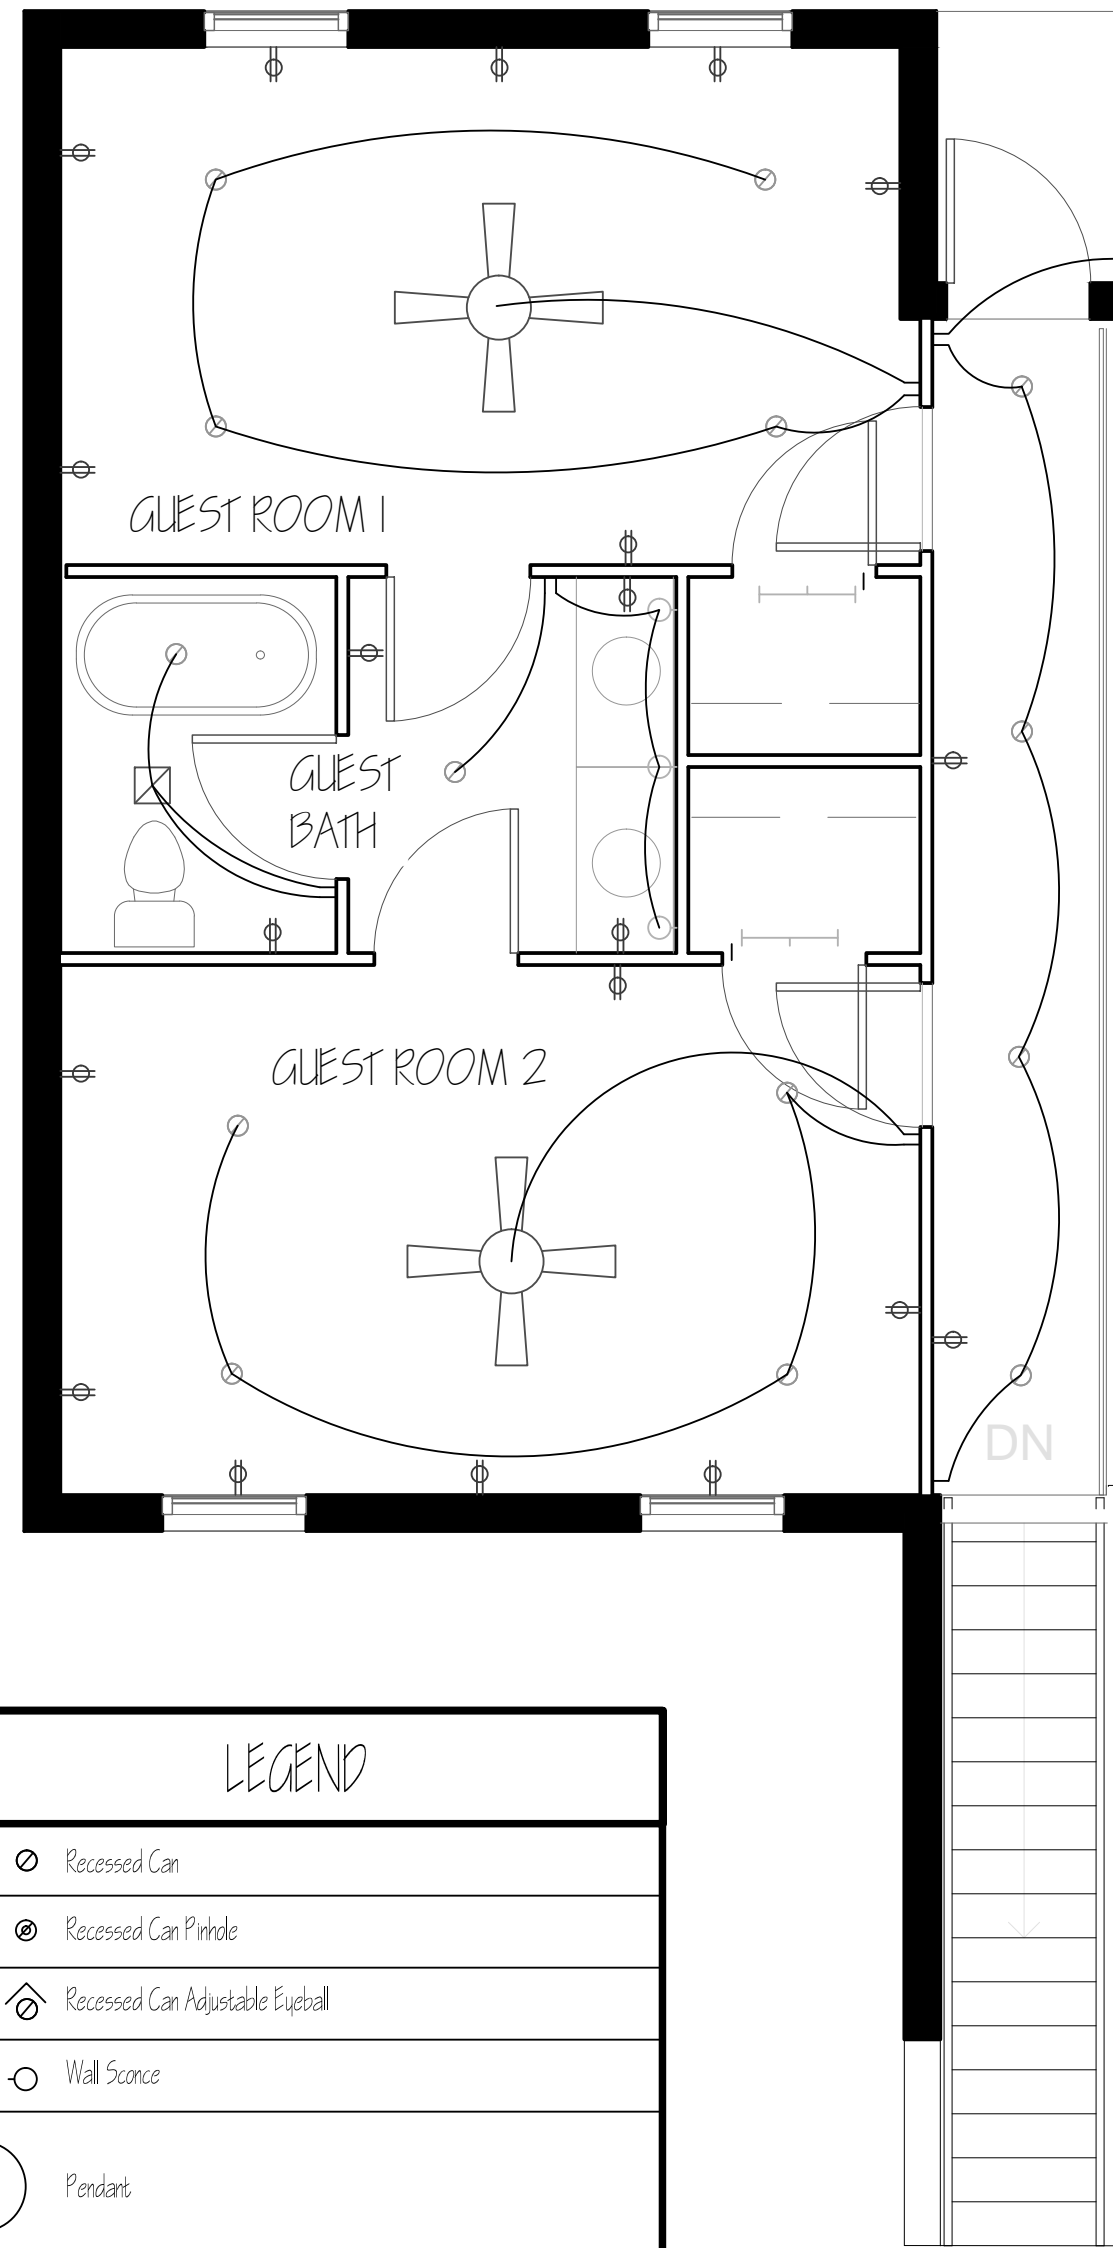


GREEN ROOF

LEVEL 1

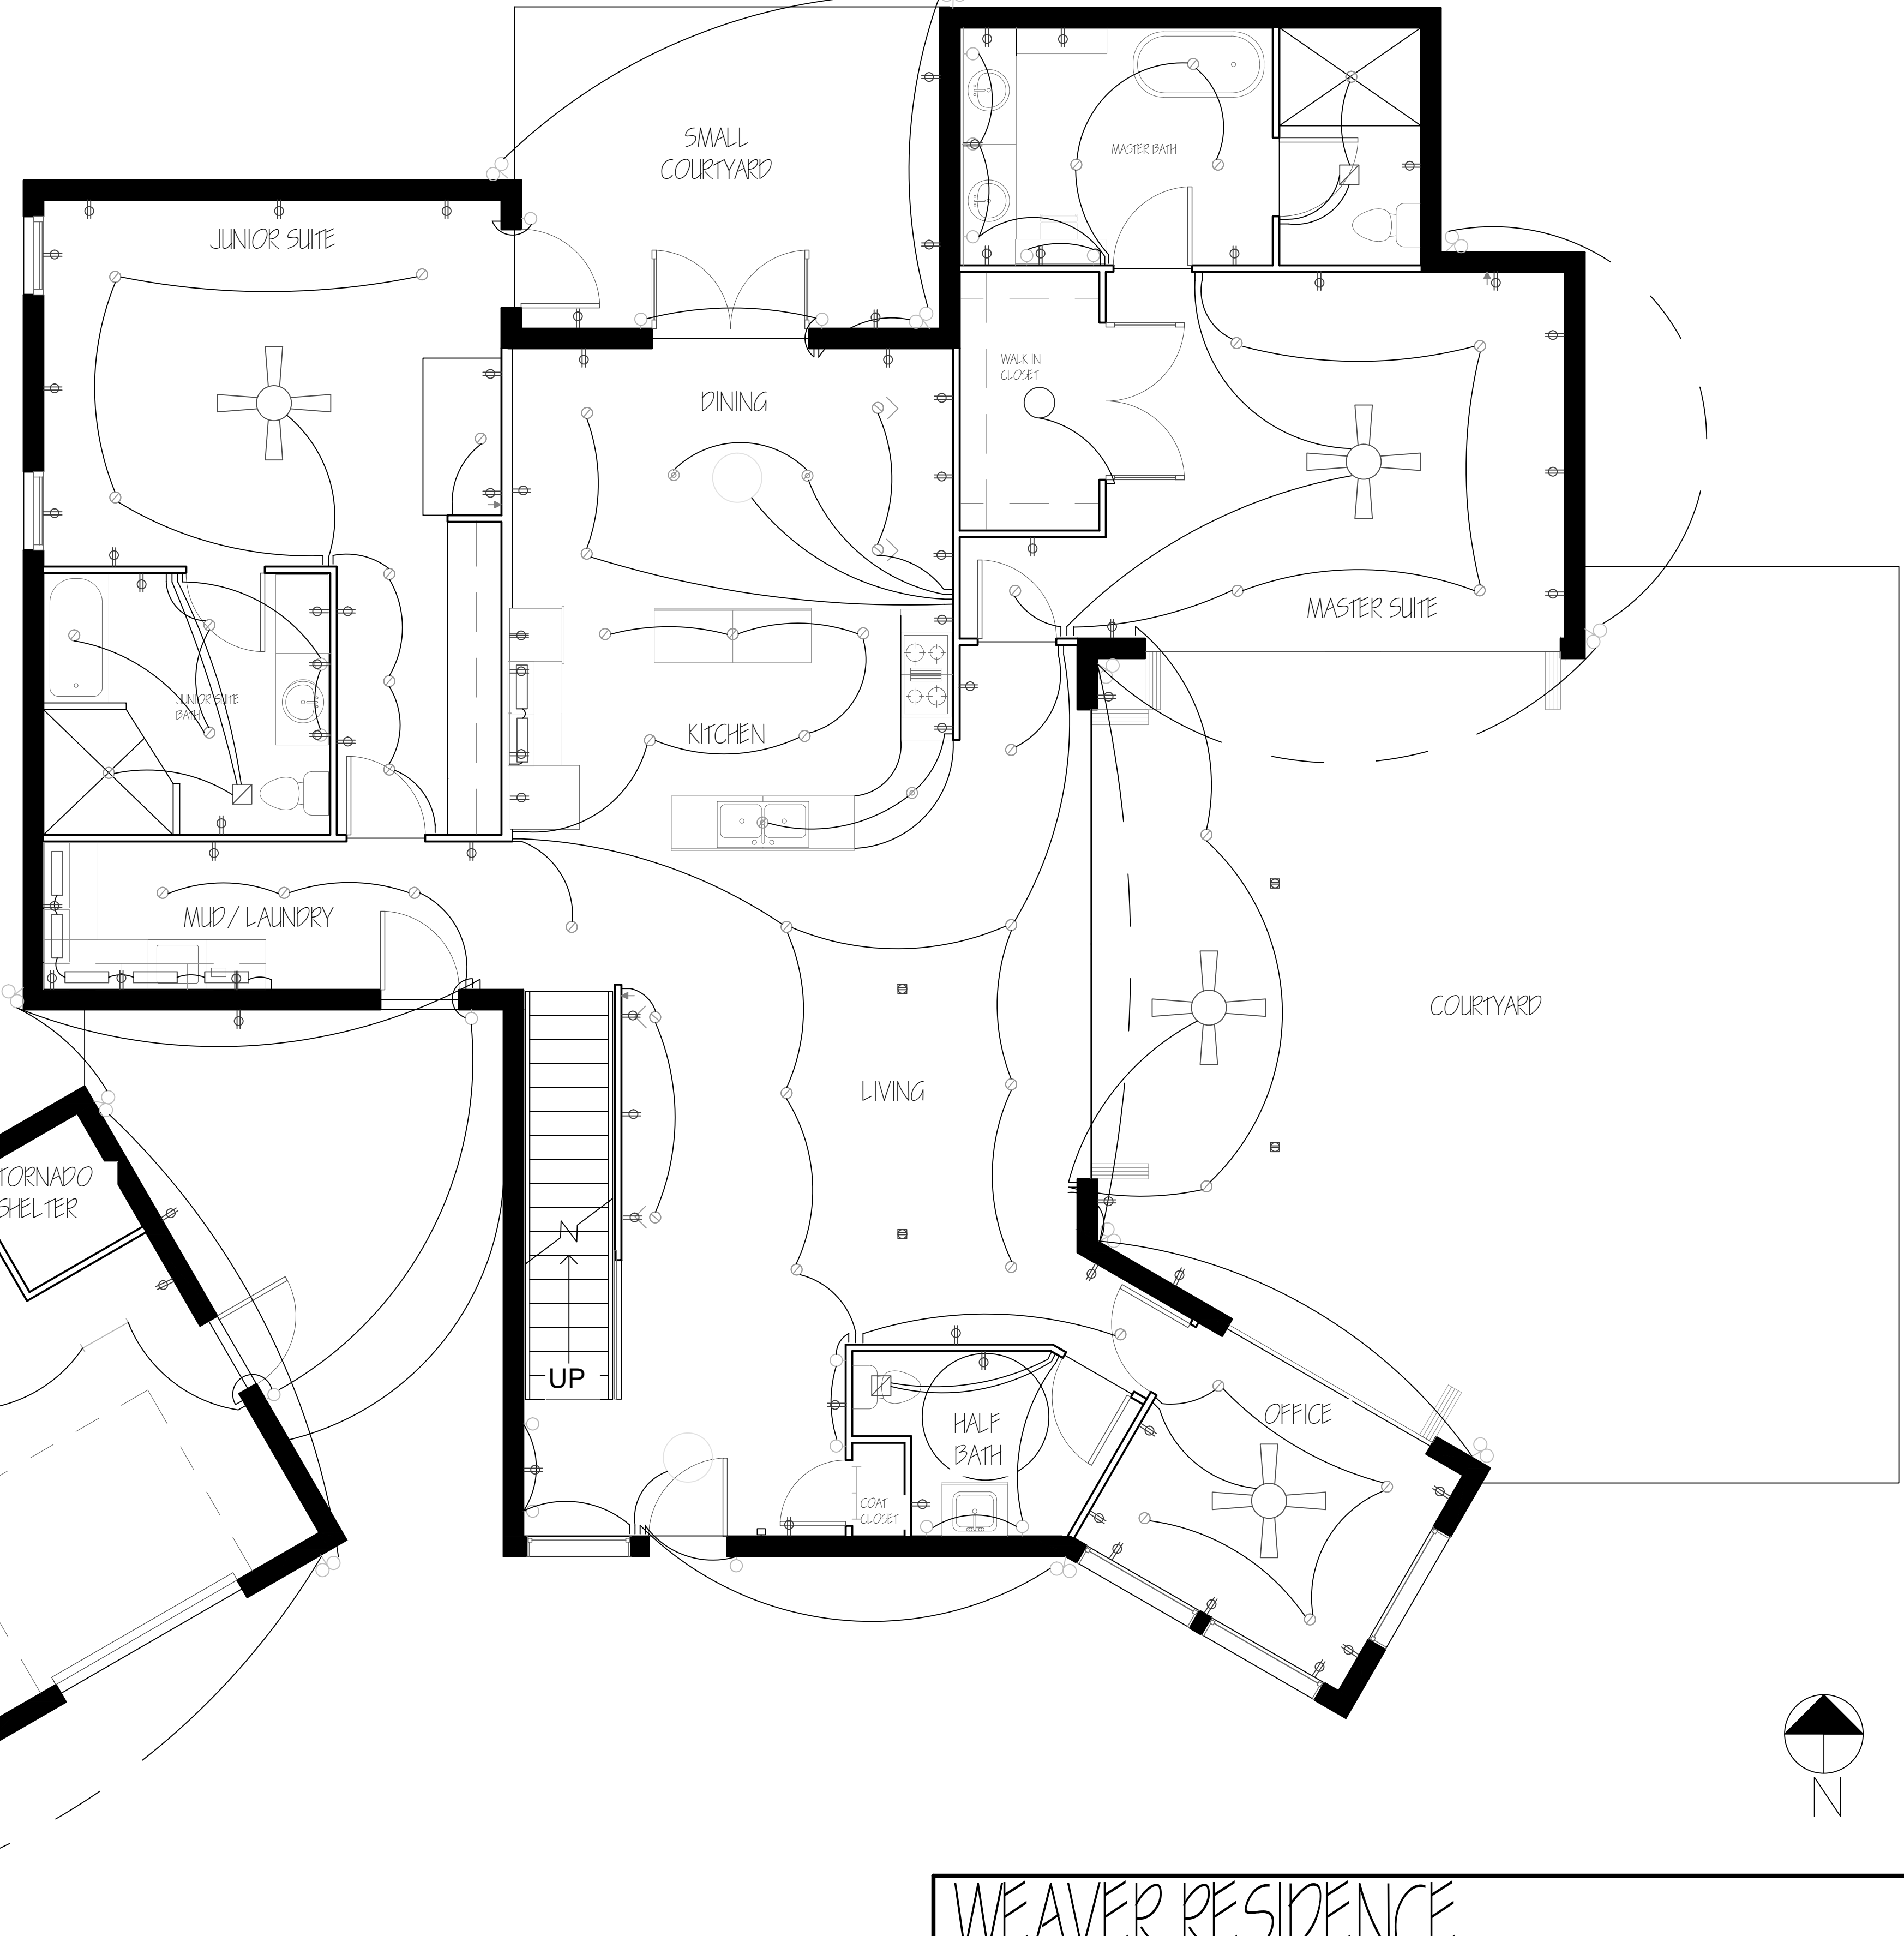

LEGEND

- Recessed Can
- Recessed Can Pinhole
- ◊ Recessed Can Adjustable Eyeball
- Wall Sconce
- Pendant
- ⊗ Safety Flood Light
- ⊠ Restroom Fan Light Combination
- Surface Mounted Fixture
- ⊕ Ceiling Fan
- ▭ Under Cabinet Task Light
- ⚡ High Voltage Receptacle Outlet
- ⇌ Duplex Receptacle Outlet
- ⚡⇌ Ground Fault Interrupt Duplex Receptacle Outlet
- ⊠ Ground Duplex Receptacle Outlet
- ☎ Telephone Line Outlet
- ⚡ Data Line Outlet
- ⌚ Single Pole Switch
- ⌚ Single Pole Switch with Dimmer
- ⌚ Three-way Single Pole Switch
- ⌚ Four-way Single Pole Switch
- Doorbell

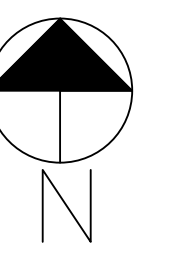

WEAVER RESIDENCE

SCALE: NYS	DRAWN BY: JUNIPER DESIGNS
DATE: SPRING 2011	
IDES 4730 RESIDENTIAL DESIGN II	
LIGHTING / ELECTRICAL PLAN WITH SWITCHING	